



KARACHI SPEAKING ROOM



Office Suite 102, 10-C Shehbaz Commercial Lane 4, Off
26th Street Phase 6


Landline: +922135172438 +922135172439 Email:
surroundarchitects@gmail.com

Logon to: www.surrounddesignstudio.com.pk


NOV 2025

SHEET INDEX


S.NO.	DRAWING TITLE	SHEET NO.
01	Demolition Layout Plan	ID-01
02	Furniture Layout Plan	ID-02
03	Dimension Layout	ID-03
04	Wall Section	ID-3A
05	Typical Wall Elevation	ID-3B
06	Flooring Layout	ID-04
07	False Ceiling Layout	ID-05

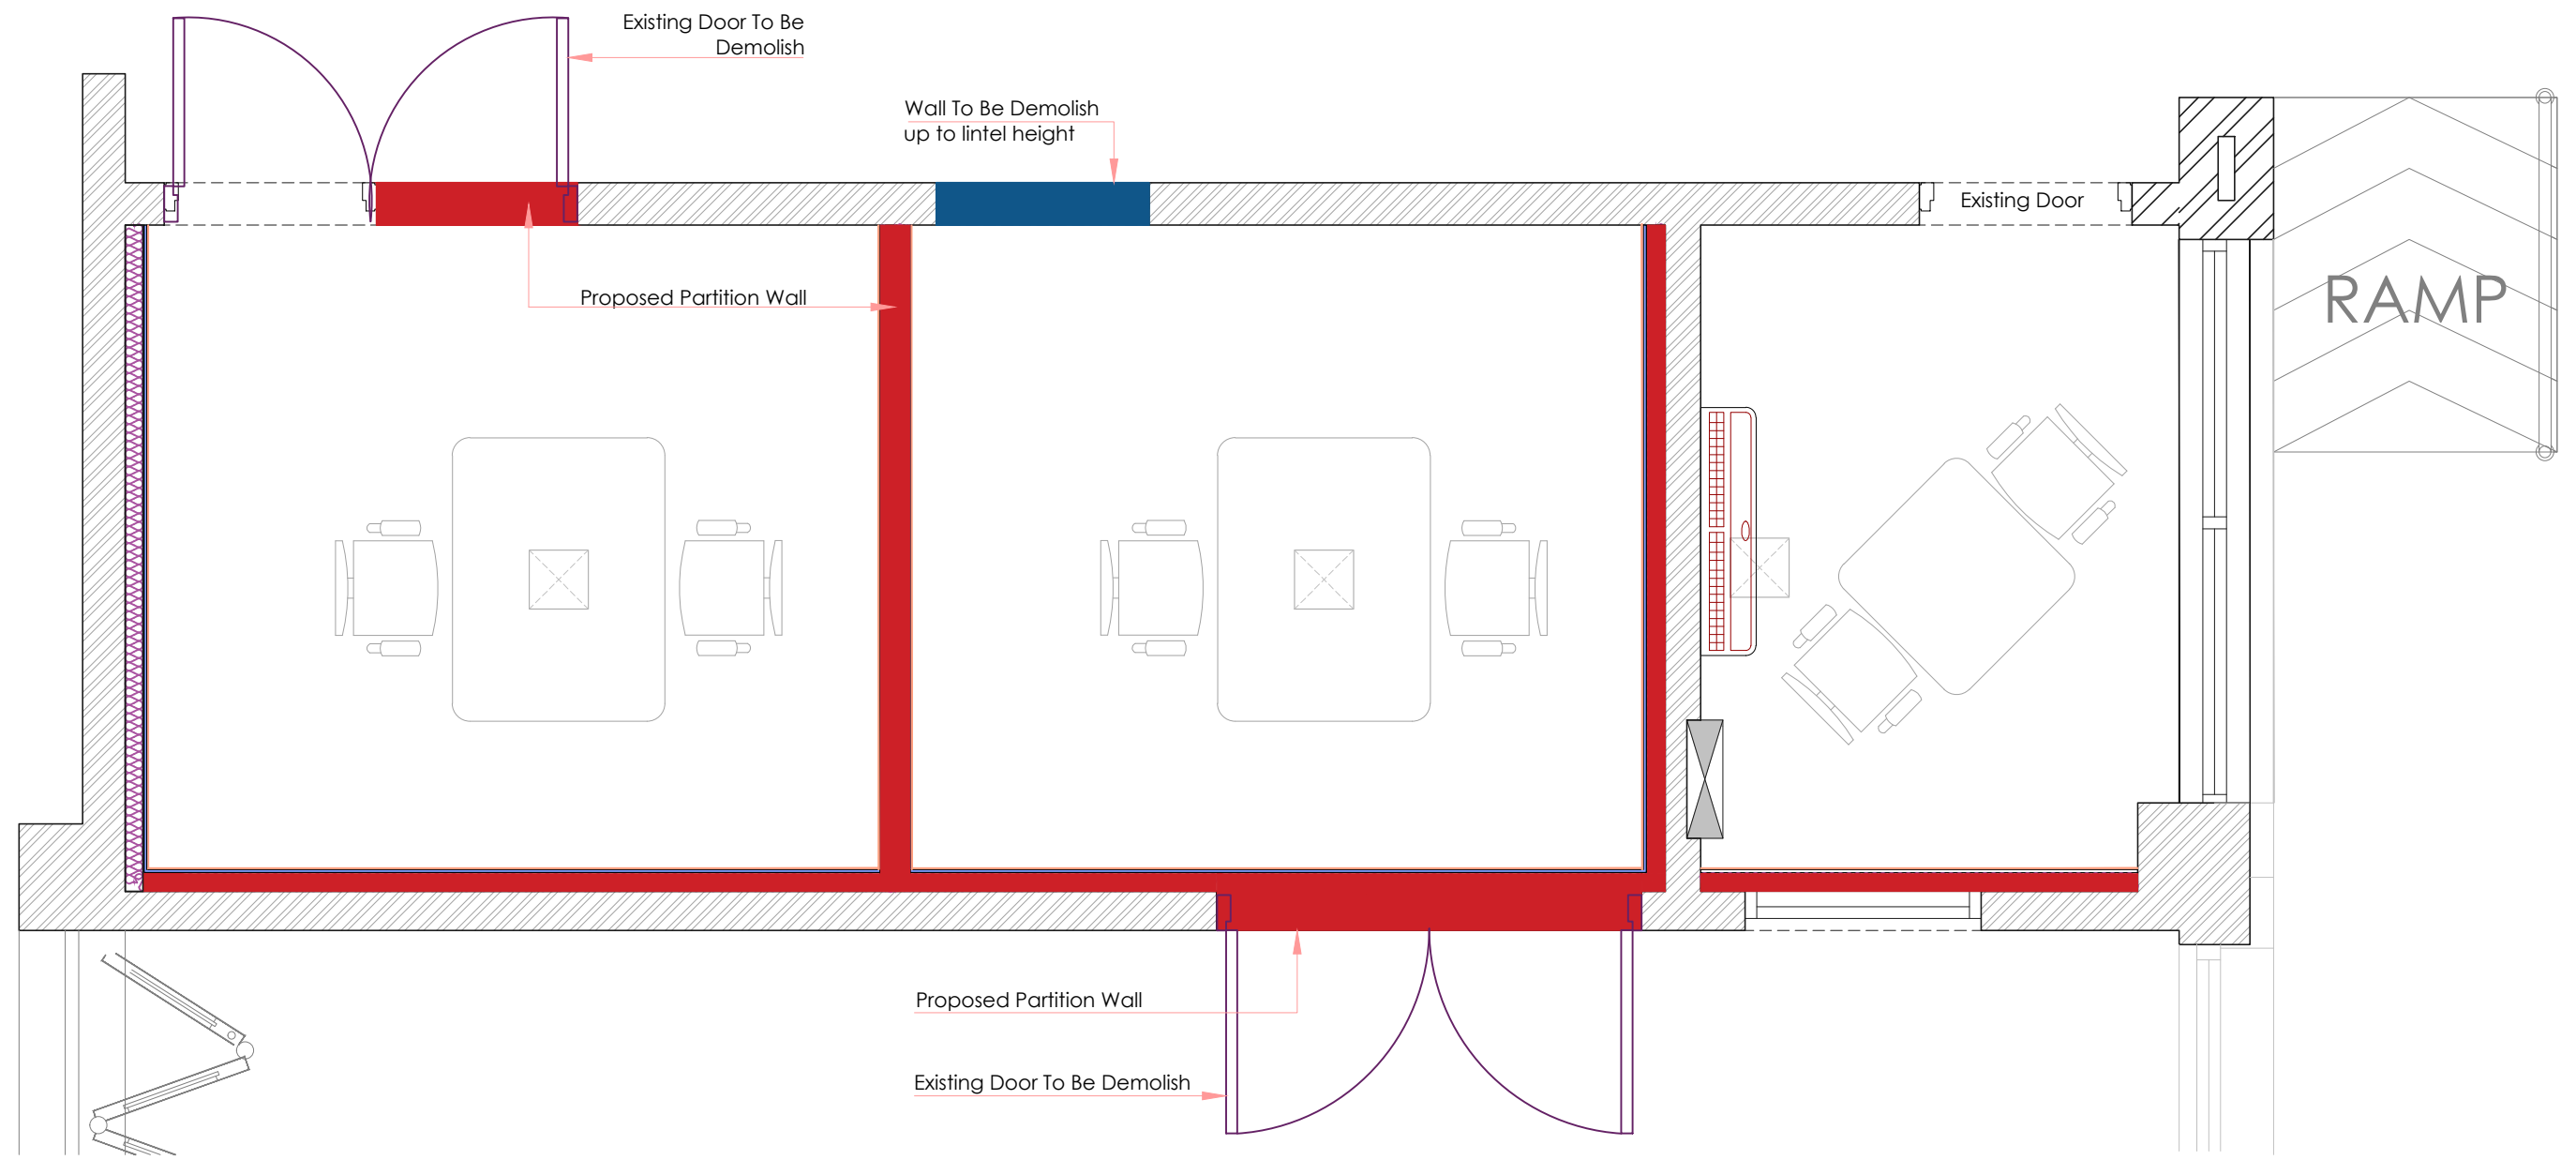


- Proposed partition / Cladding with sound proof insulation
- Wall dismantled up-to lintel height

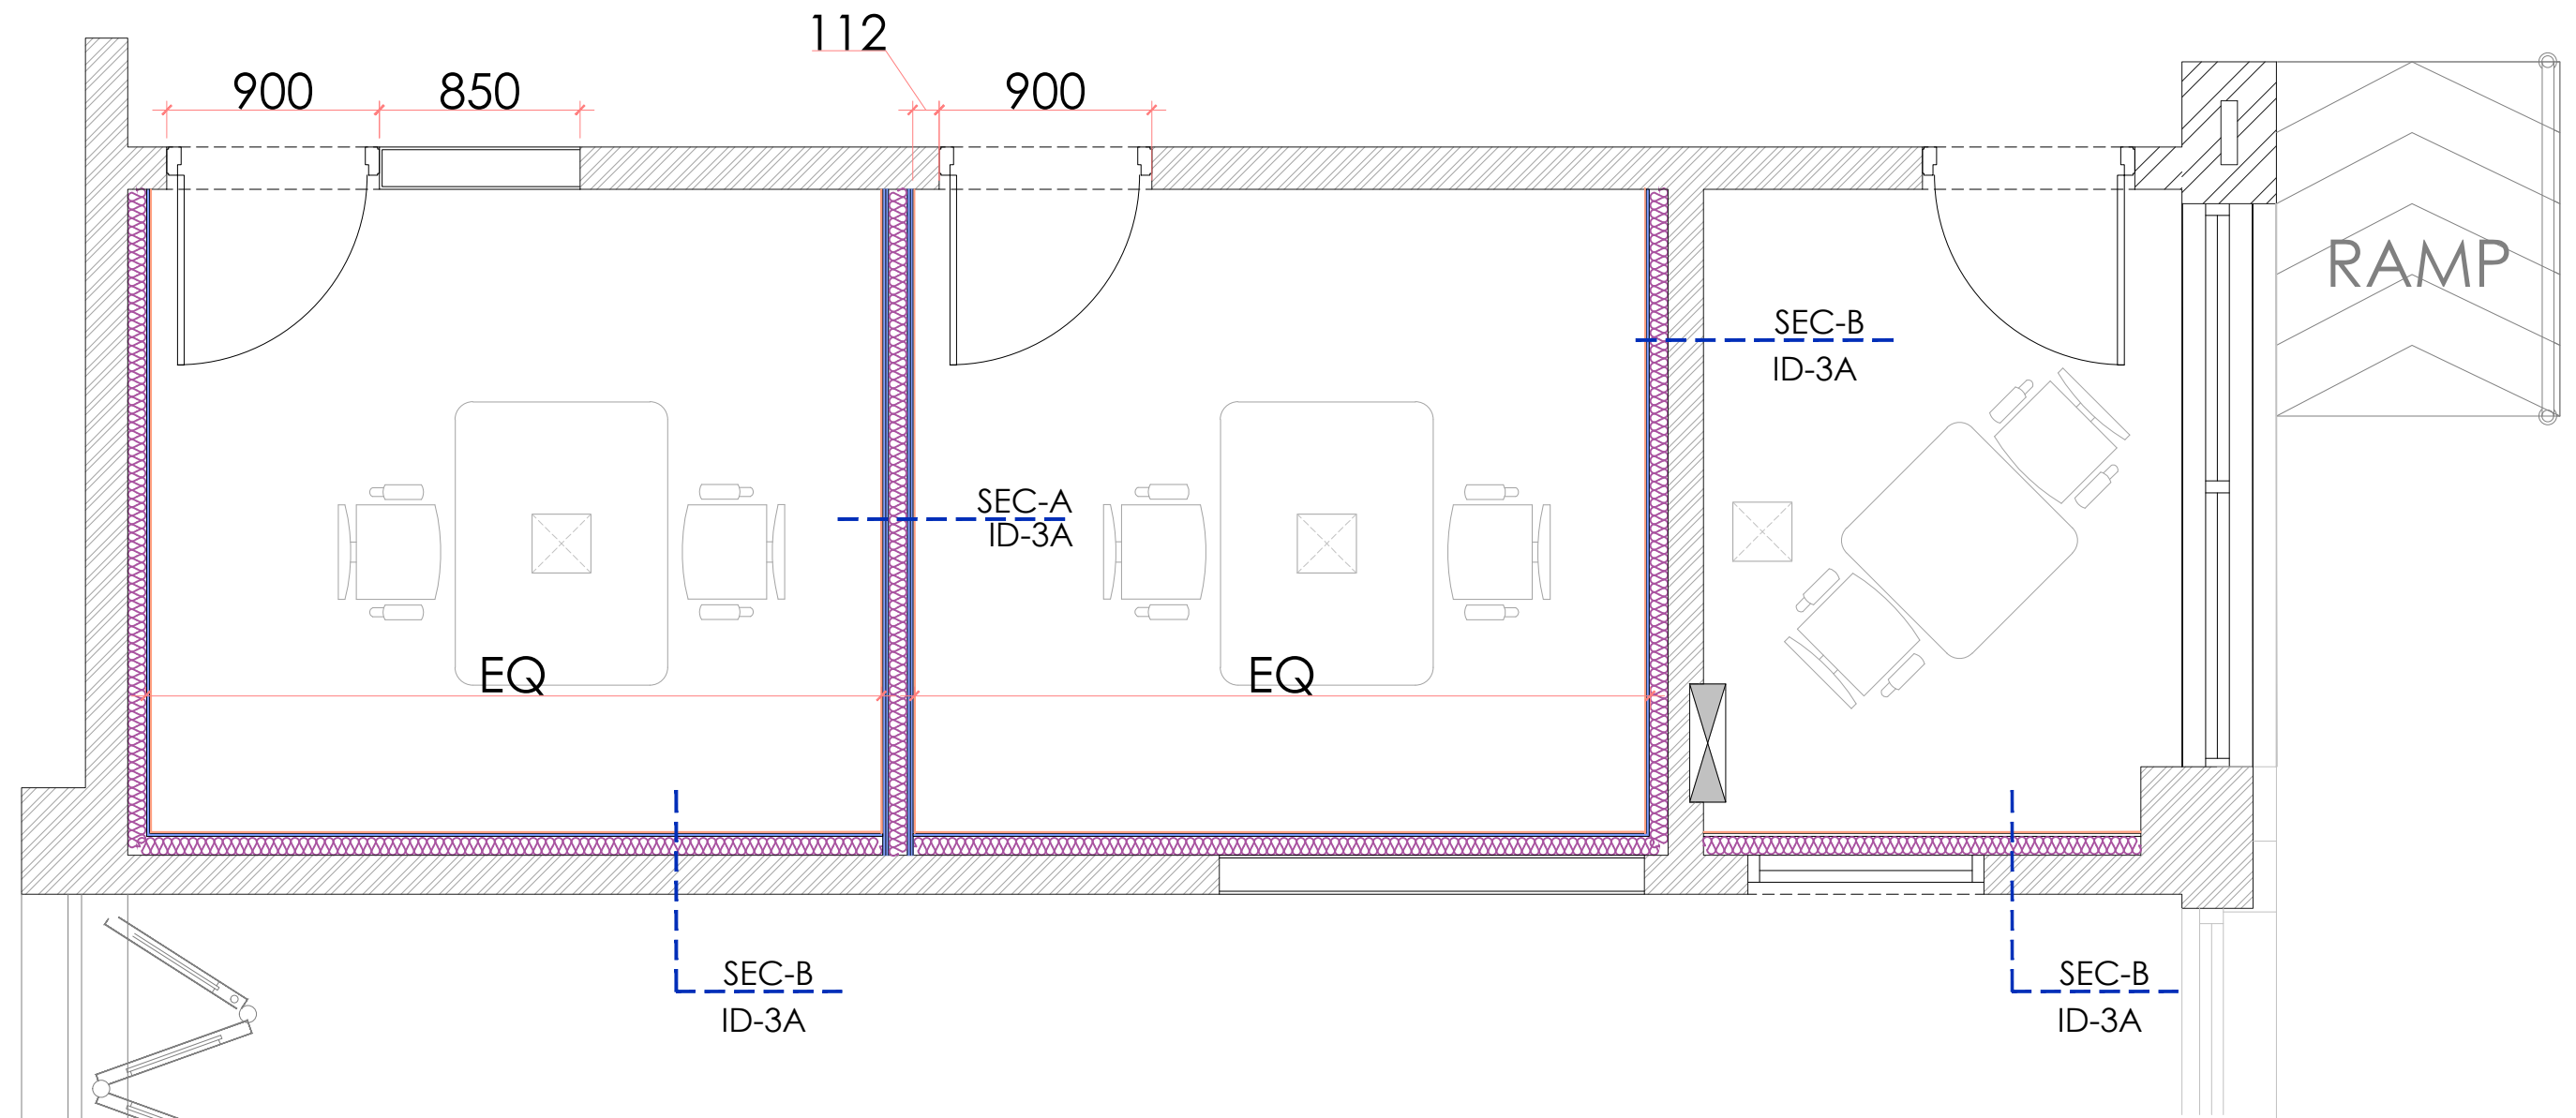


PROJECT BRITISH COUNCIL LIBRARY - KARACHI	TITLE DIMENSION PLAN TALK ROOM	REVISION	JOB NO.:	ELECTRIC CONSULTANTS	HVAC CONSULTANT	ARCHITECTS SURROUND Office Suite 102, 10-C Shehbaz Commercial Lane 4, Off 26th Street Phase 6 Landline: +922135172438 +922135172439 Email: surroundarchitects@gmail.com Logon to: www.surroundarchitects.com	DATE: Nov-2025 SCALE: 1:30 DRG. NO.: ID-03
			REMARKS				
			DRAWN BY: SURR				
			CHECKED BY: SURR				

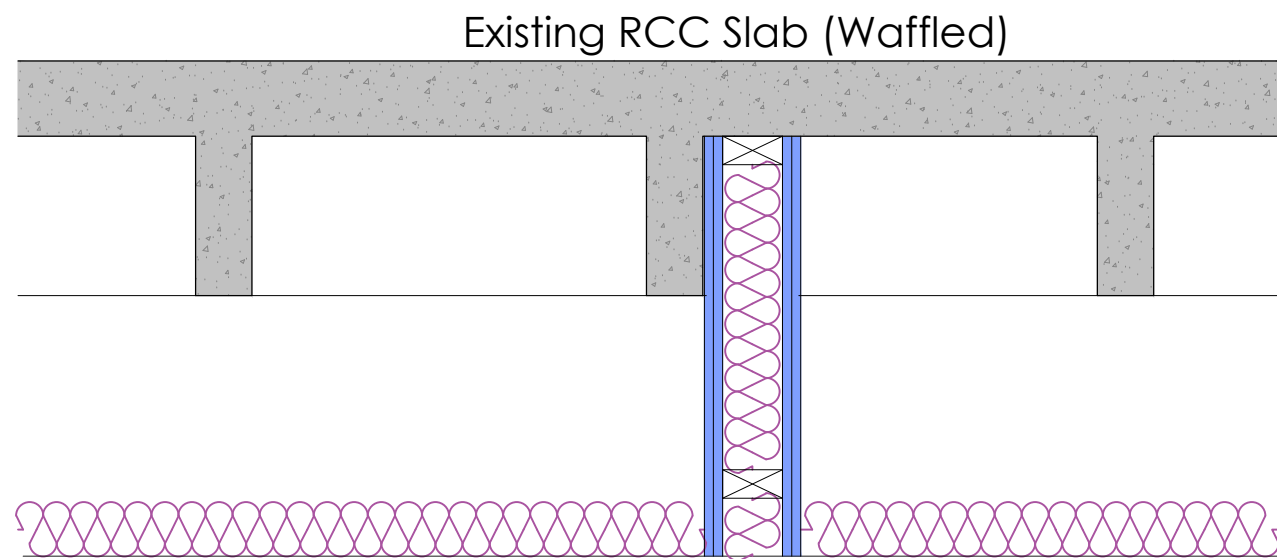

AC DUCT

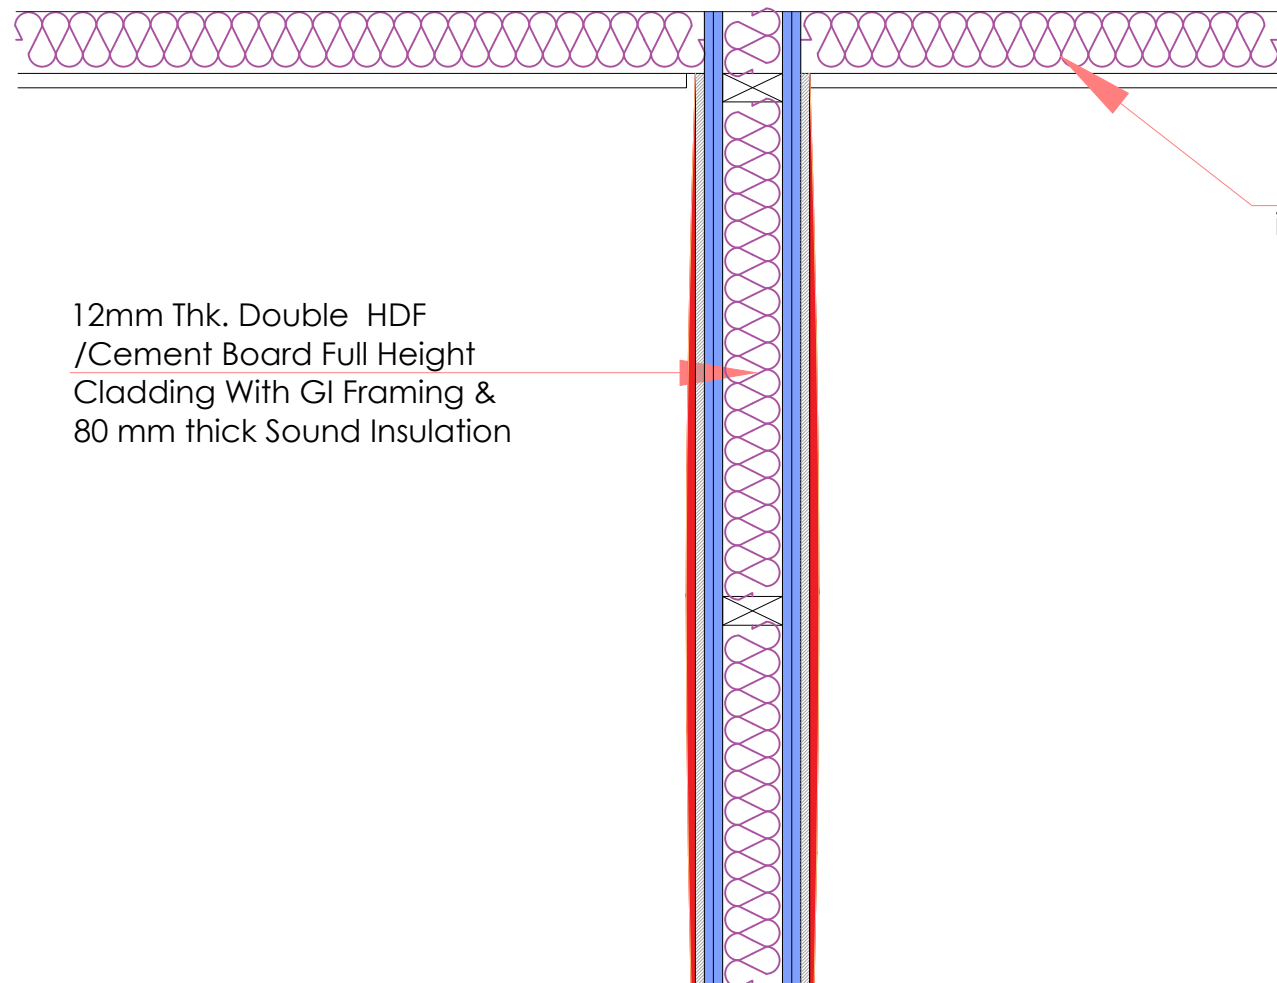

SECTION-A

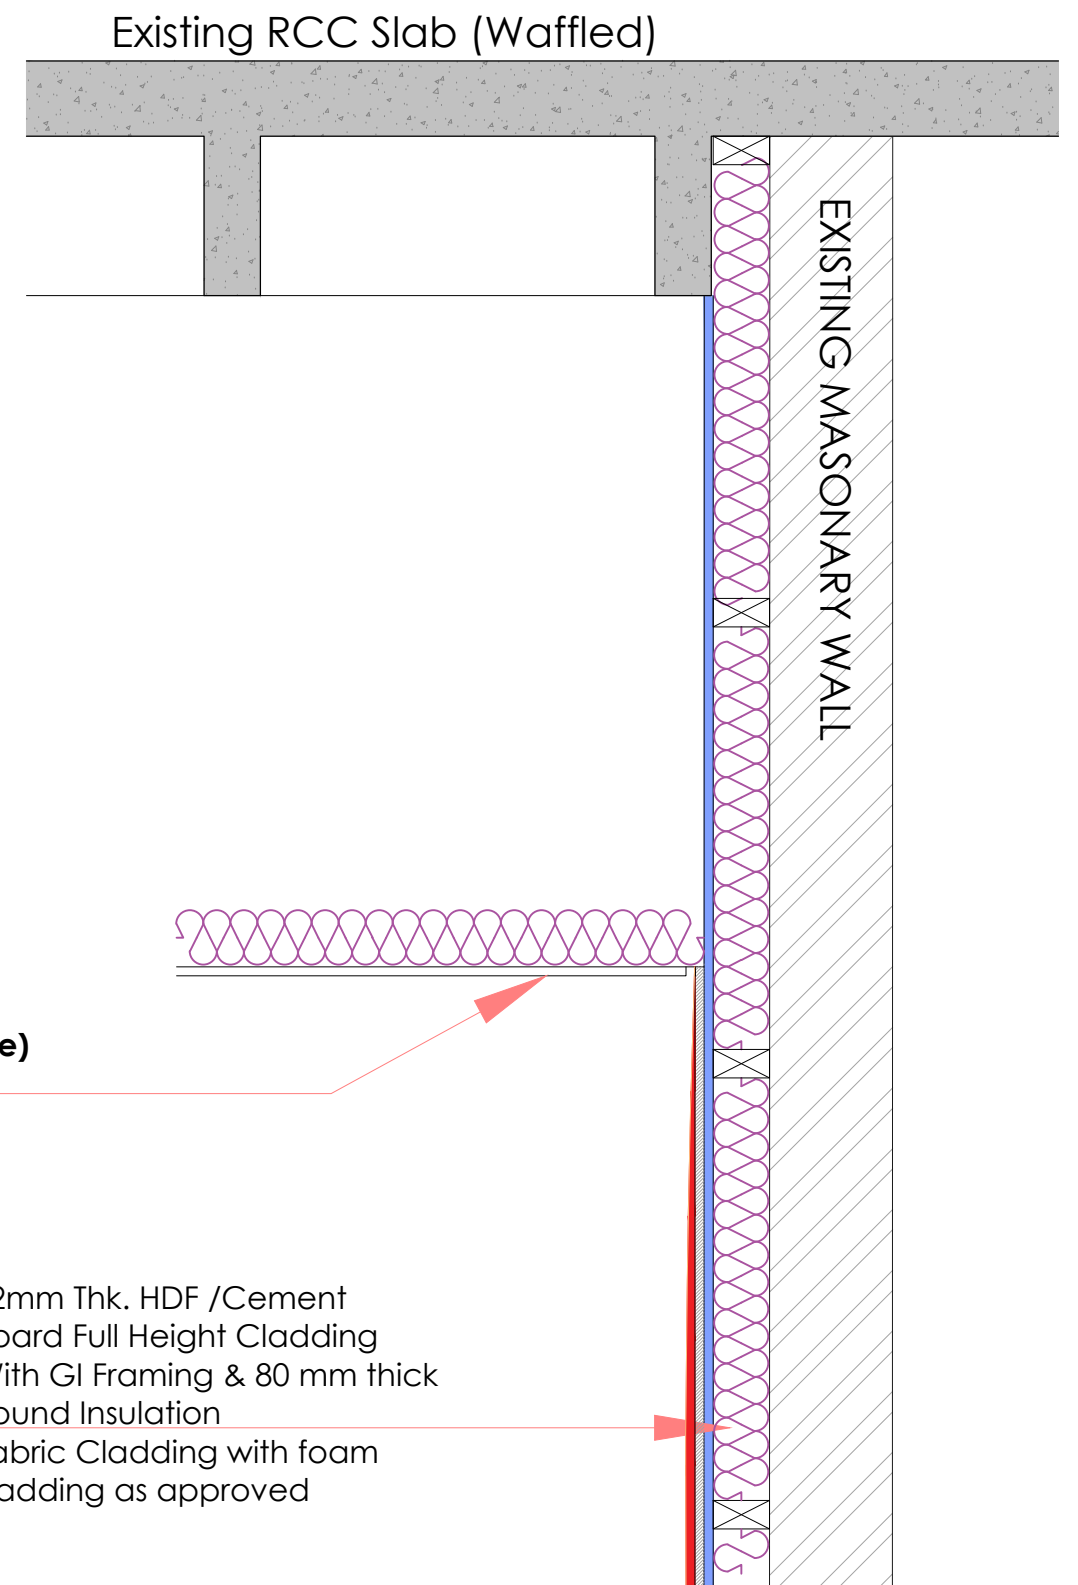



SECTION-B


±2700
(as per site)


Gypsum Ceiling Drop
Panel Paint Finish with
insulation sheet above



12mm Thk. Double HDF
/Cement Board Full Height
Cladding With GI Framing &
80 mm thick Sound Insulation


12mm Thk. HDF /Cement
Board Full Height Cladding
With GI Framing & 80 mm thick
Sound Insulation
Fabric Cladding with foam
padding as approved

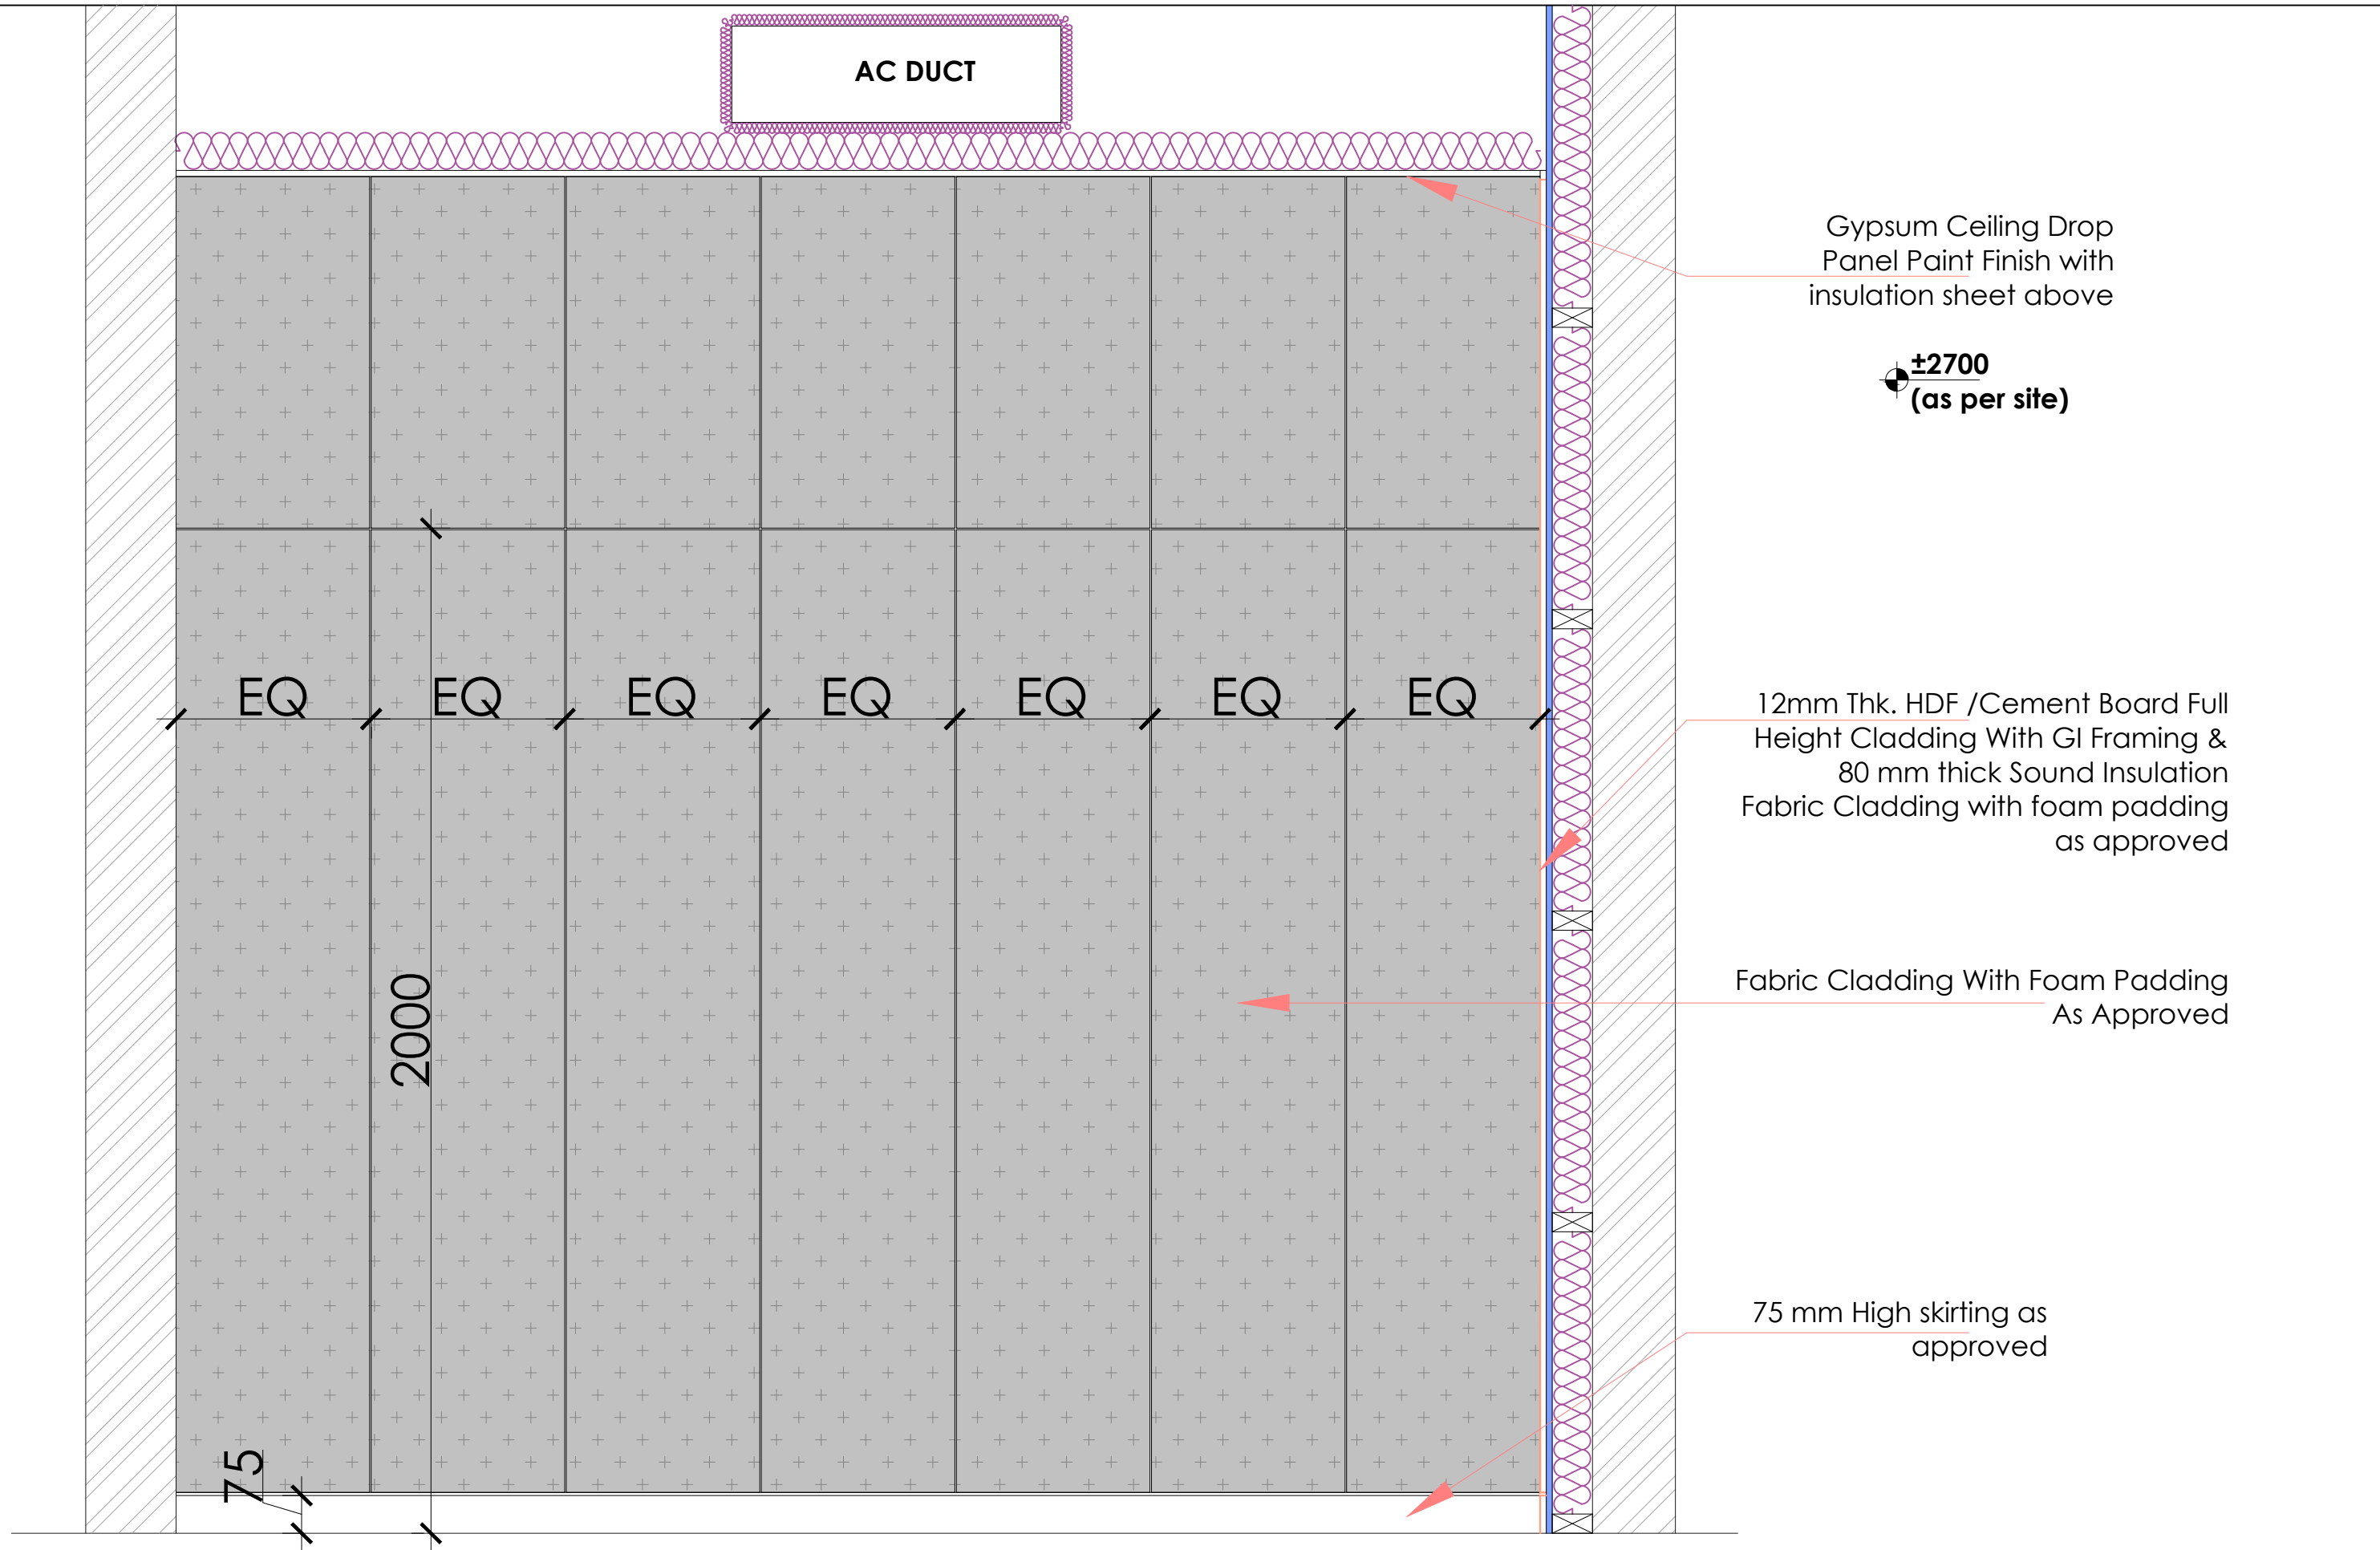PROJECT	TITLE	REVISION	JOB NO.:	ELECTRIC CONSULTANTS	HVAC CONSULTANT	ARCHITECTS	DATE
 BRITISH COUNCIL LIBRARY - KARACHI	WALL SECTION TALK ROOM		REMARKS			 Surr+Ind Office Suite 102, 10-C Shehbaz Commercial Lane 4, Off 26th Street Phase 6 Landline: +922135172438 +922135172439 Email: surrindarchitects@gmail.com Logon to: www.surrindarchitects.com	Nov-2025
			DRAWN BY				SCALE:
			CHECKED BY				1:10
							DRG.NO.:
							ID-3A

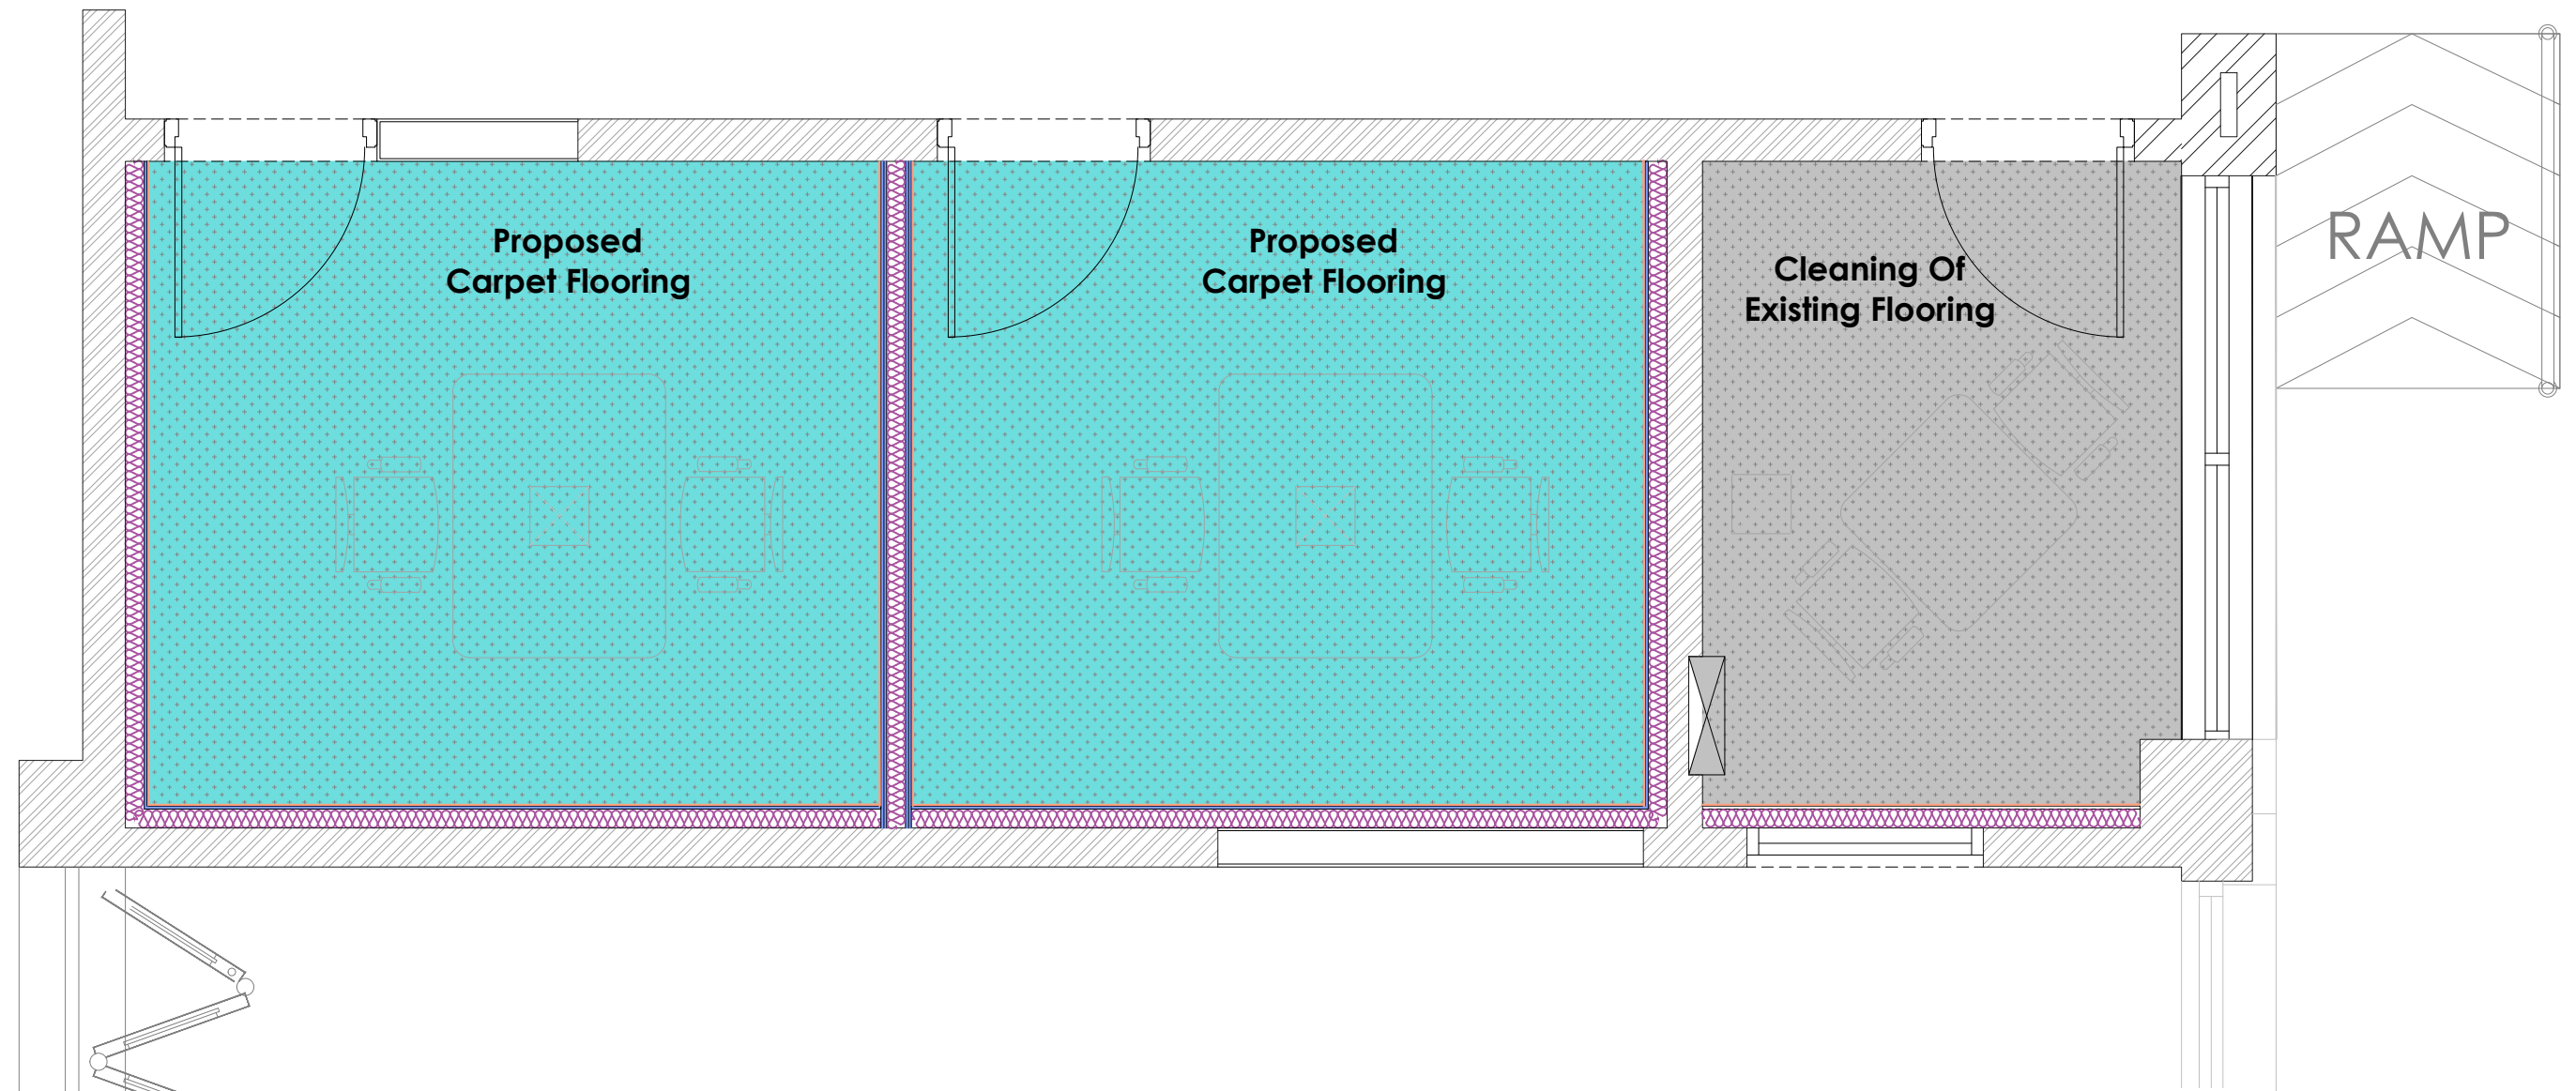



<div>PROJECT</div> <div> BRITISH COUNCIL</div> <div>LIBRARY - KARACHI</div>	<div>TITLE</div> <div>FLOORING PLAN</div> <div>TALK ROOM</div>	REVISION	JOB NO.:	ELECTRIC CONSULTANTS	HVAC CONSULTANT	<div>ARCHITECTS</div> <div> SURROUND</div> <div>Office Suite 102, 10-C Shehbaz Commercial Lane 4, Off 26th Street Phase 6 Landline: +922135172438 +922135172439 Email: surroundarchitects@gmail.com Logon to: www.surroundarchitects.com</div>	DATE: Nov-2025
			REMARKS				
			DRAWN BY: SURR				SCALE: 1:30
			CHECKED BY: SURR				DRG.NO.:
							ID-04

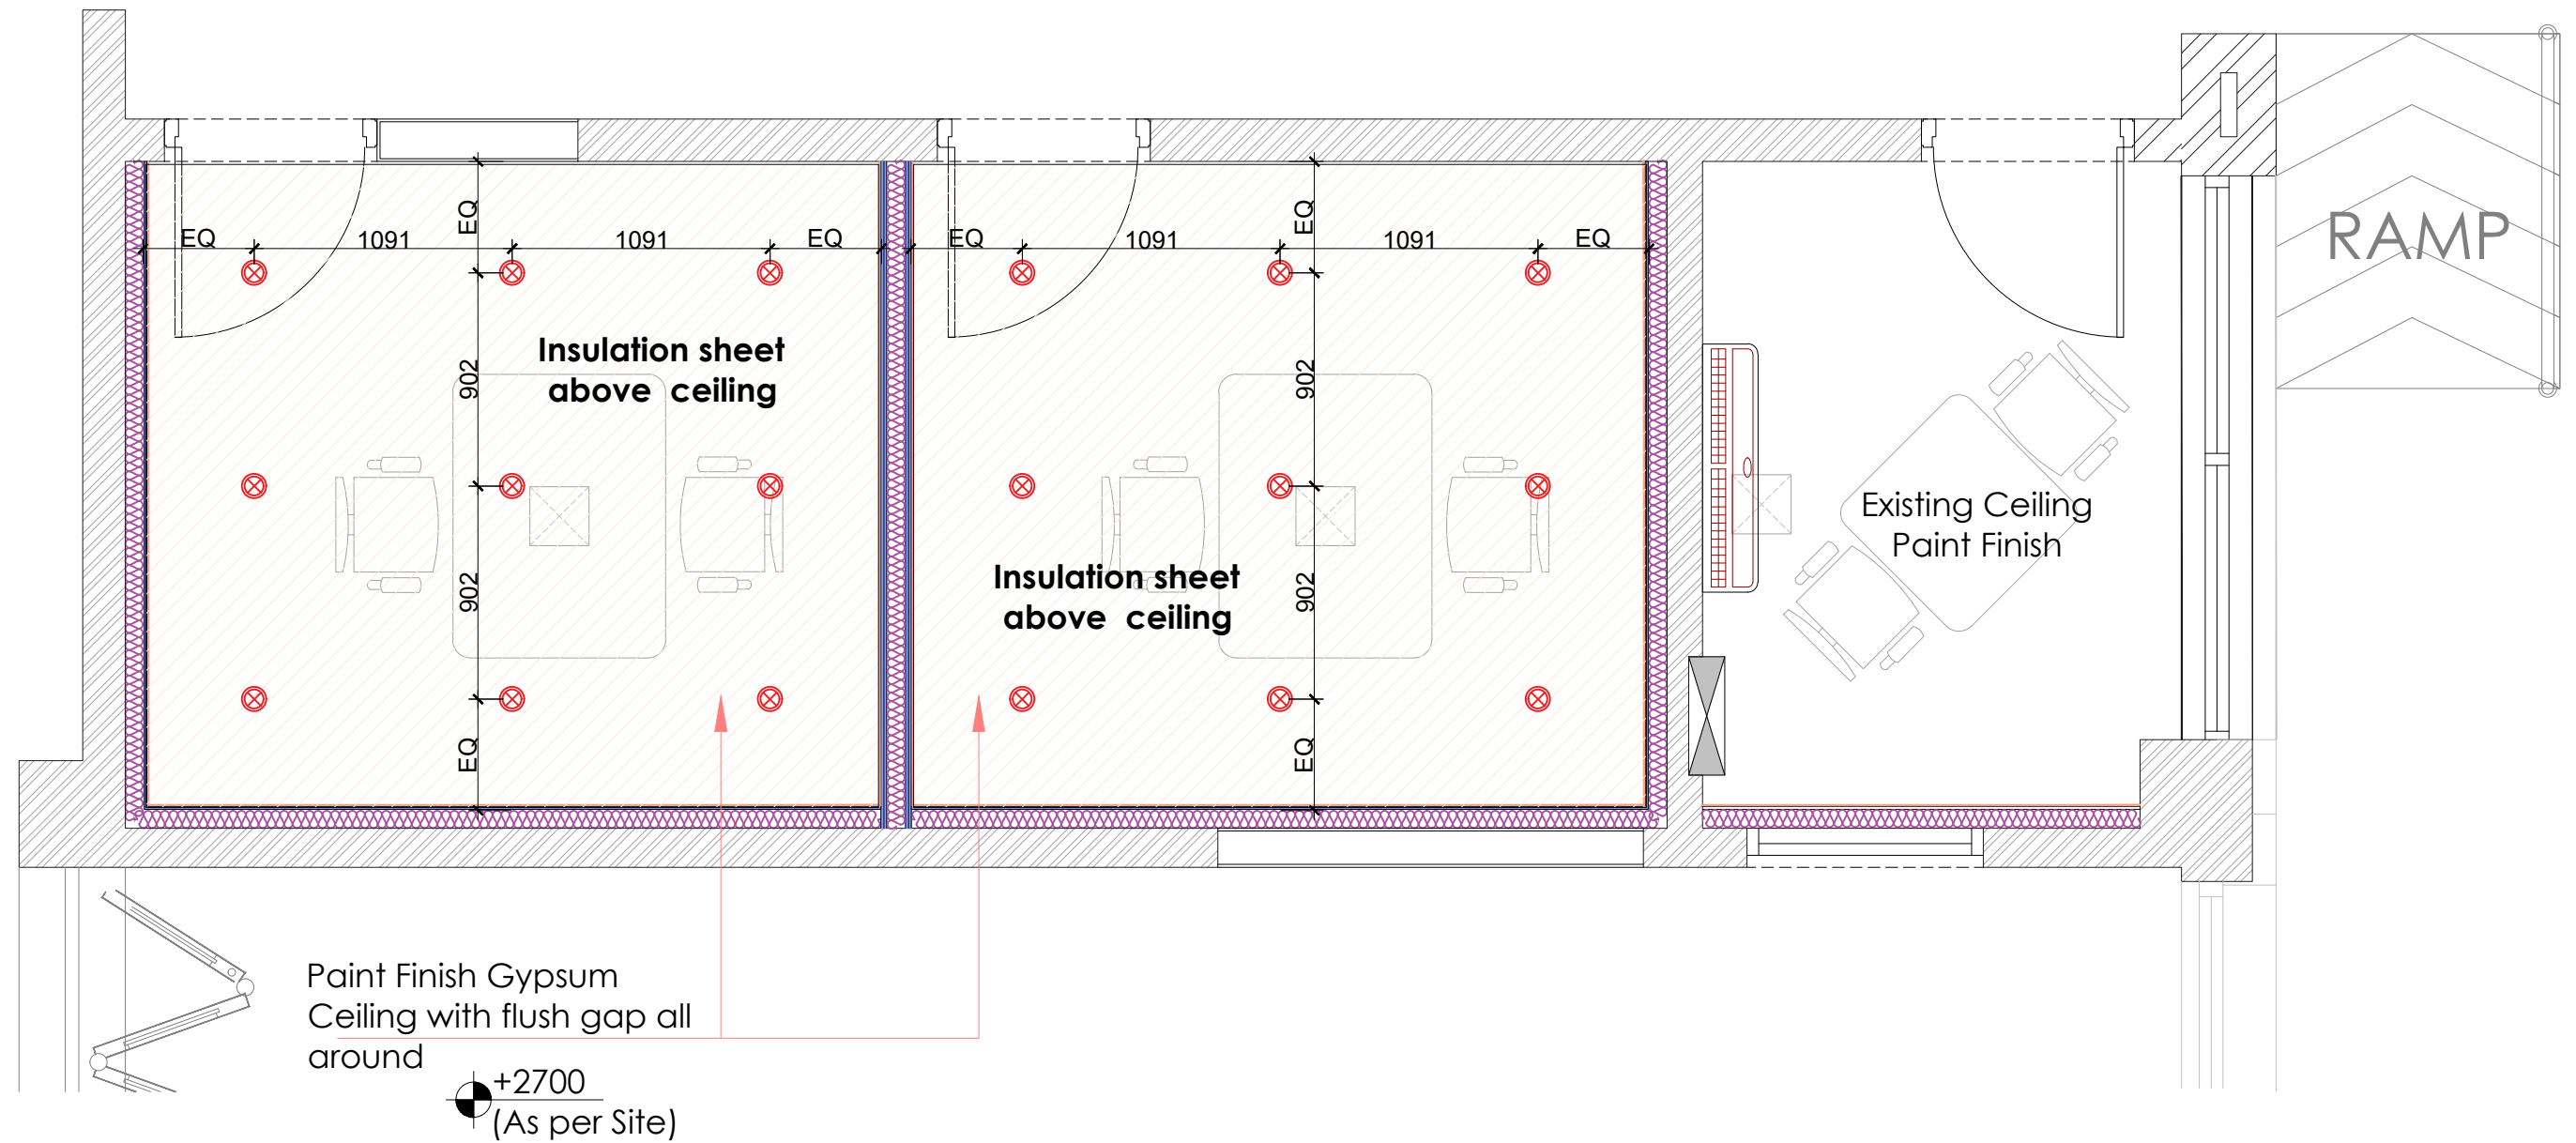

NOTE:
FOR AC supply and Return grills refer the HVAC shop drawings.

PROJECT	TITLE	REVISION	JOB NO.:	ELECTRIC CONSULTANTS	HVAC CONSULTANT	ARCHITECTS	DATE:
BRITISH COUNCIL LIBRARY - KARACHI	CEILING PLAN TALK ROOM		REMARKS			Surr-Ind Office Suite 102, 10-C Shehbaz Commercial Lane 4, Off 26th Street Phase 6 Landline: +922135172438 +922135172439 Email: surrindarchitects@gmail.com Logon to: www.surrindarchitects.com	Nov-2025
			DRAWN BY: SURR				SCALE: 1:30
			CHECKED BY: SURR				DRG.NO.: ID-05